
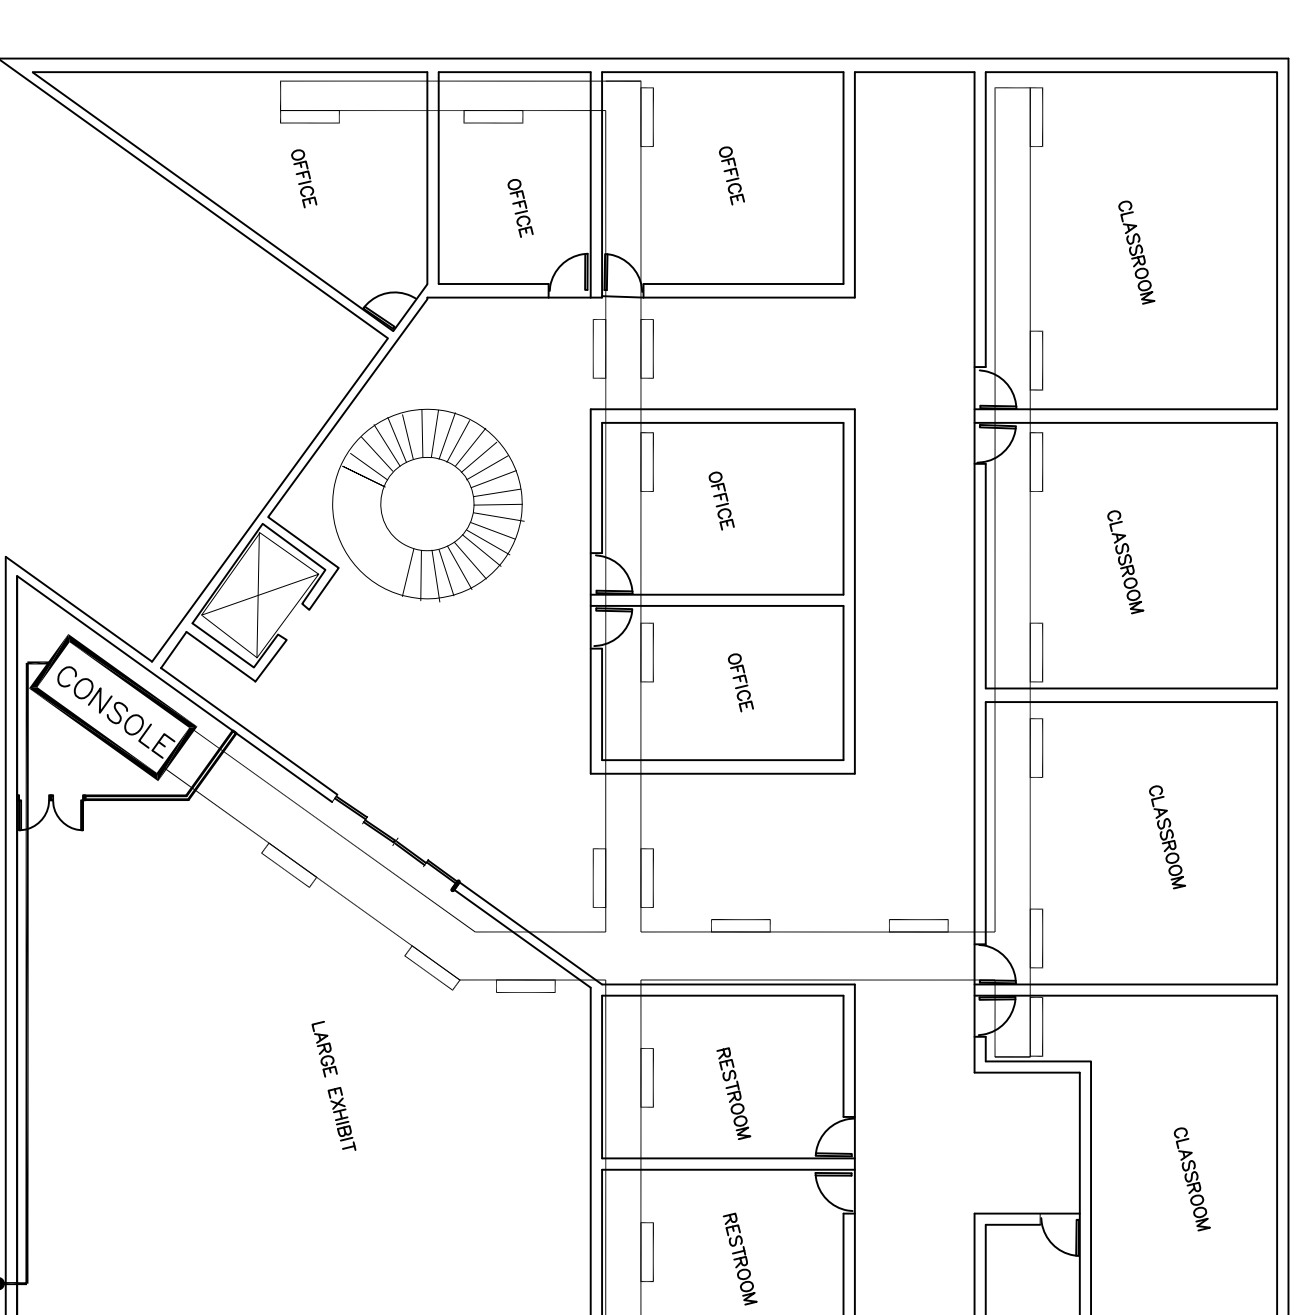
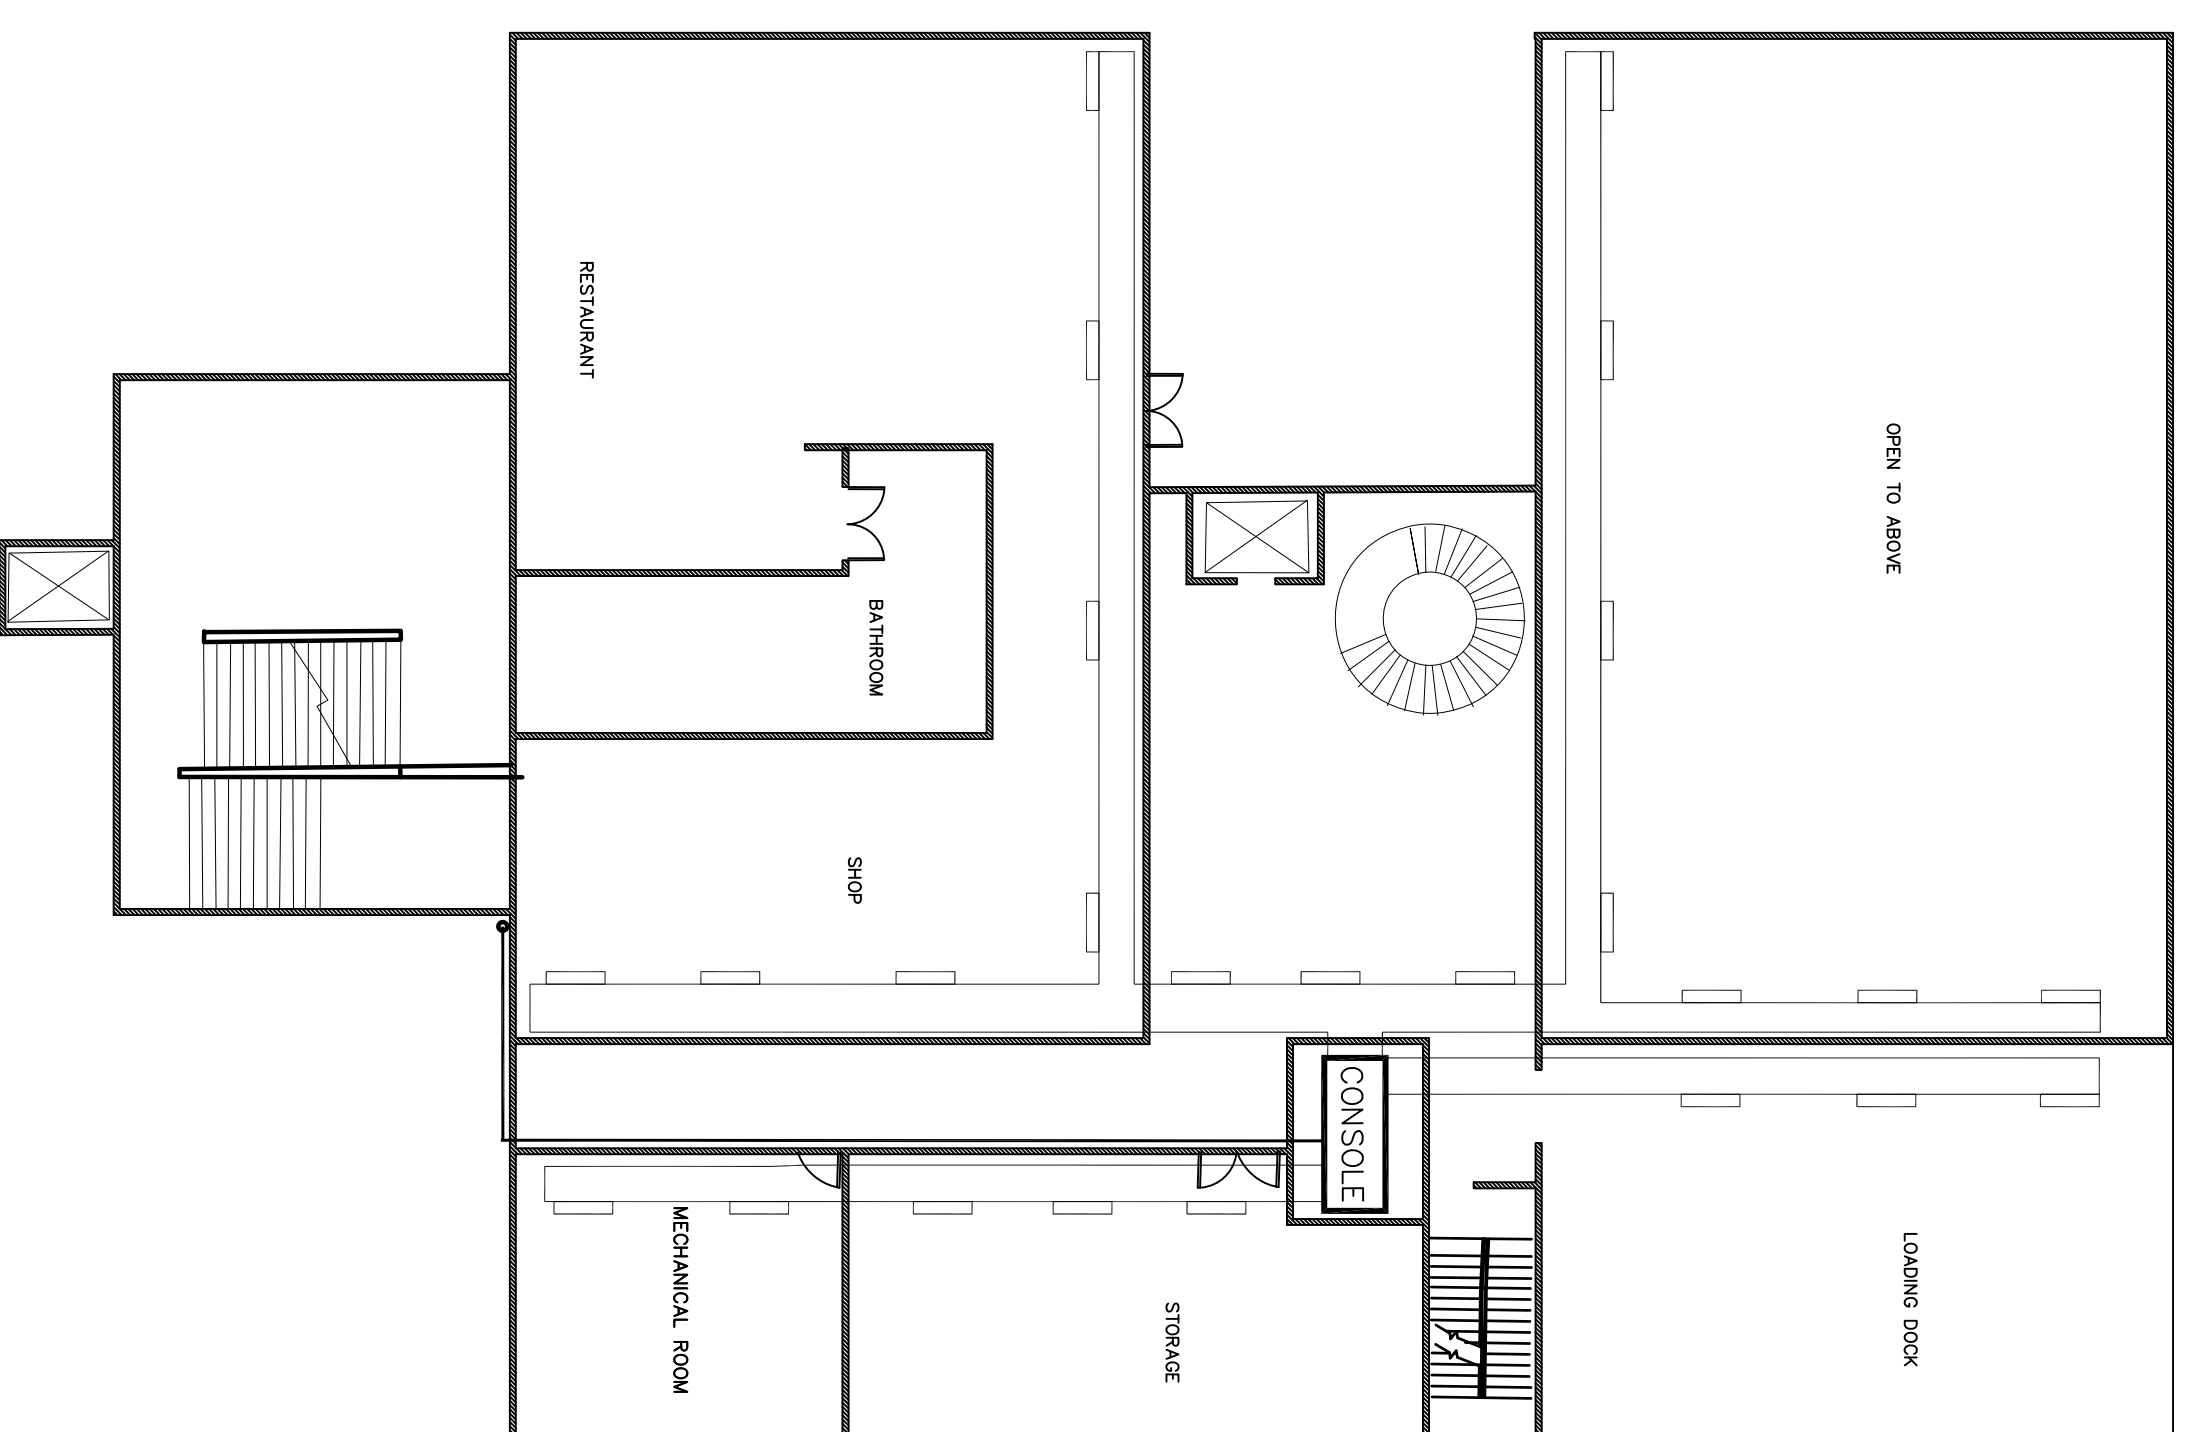


# Mechanical Plan

Address  
Cathedral Pt, Brooklyn, NY, 11201

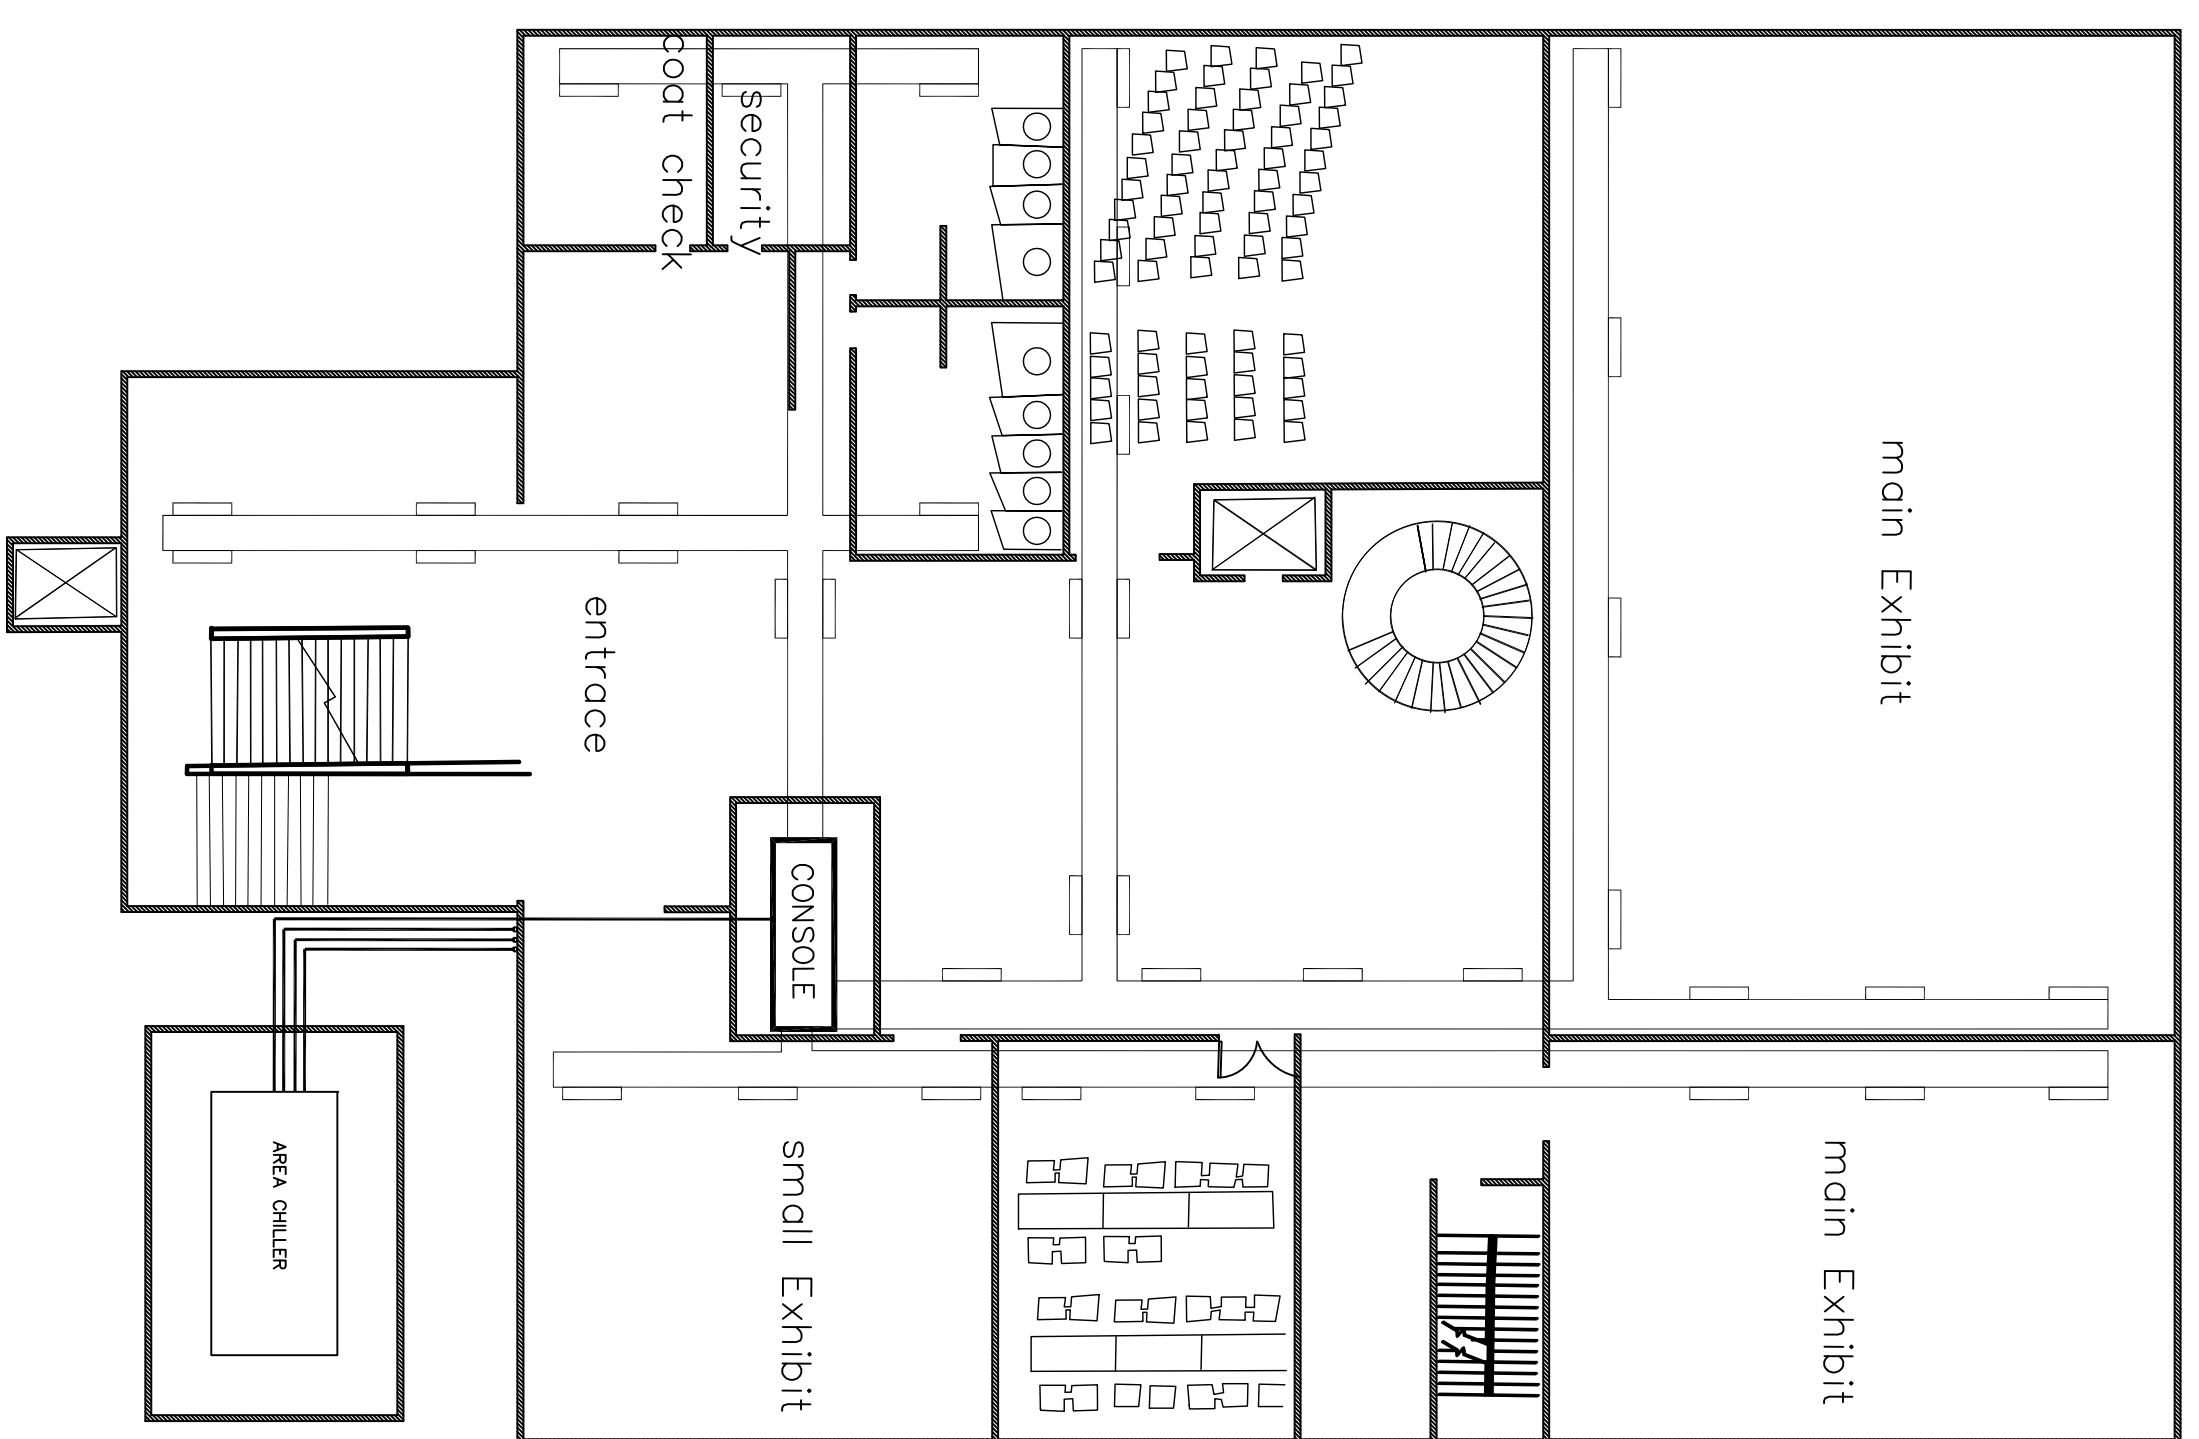

Date 03/03/2016  
Drawn by Richa, Amy, All, Jose  
Professor Name King

Scale 1" = 1'-0"