
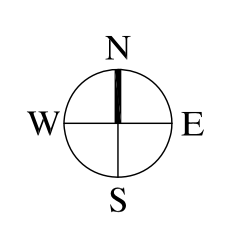


TRINITY COLLEGE LIBRARY

College Street,
Dublin City Centre

Student Name:
REN, YING
Brooklyn Office:
Department of Architectural Technology
186 Jay Street, Brooklyn New York

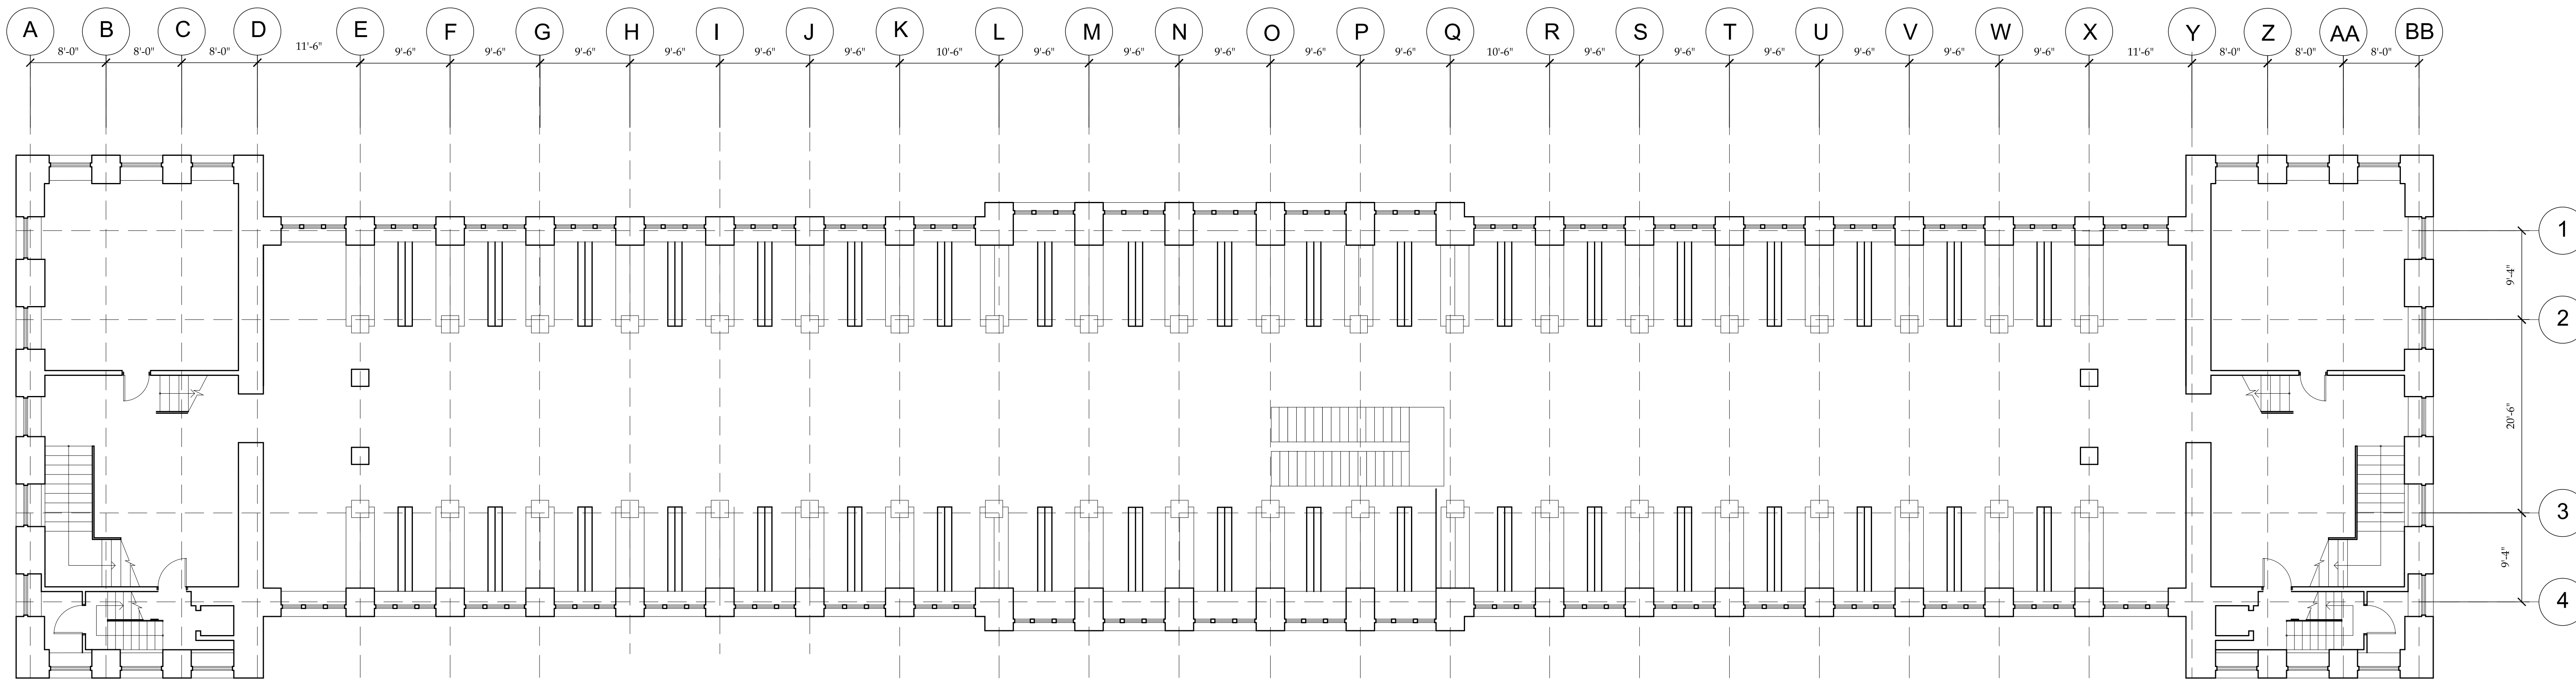

DATE OF FIRST ISSUE:	MONTH DD, YYYY
5/20/17	

PROJECT	
MAJOR CASE STUDY	
DWG TITLE	
FIRST FLOOR PLAN	
SEAL & SIGNATURE	DATE: 2017 05 26
	PROJECT NO.: YYYY_NN
	DRAWING BY: YING REN
	CHK BY: JAM / TMA
	DWG NO.:
	A-101.00
CADD FILE NO.:	PAGE:
XXX-101.00_XXXX	2 OF 8