
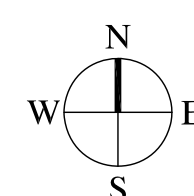


TRINITY COLLEGE LIBRARY

College Street,  
Dublin City Centre

Student Name:  
**REN, YING**  
Brooklyn Office:  
Department of Architectural Technology  
186 Jay Street, Brooklyn New York

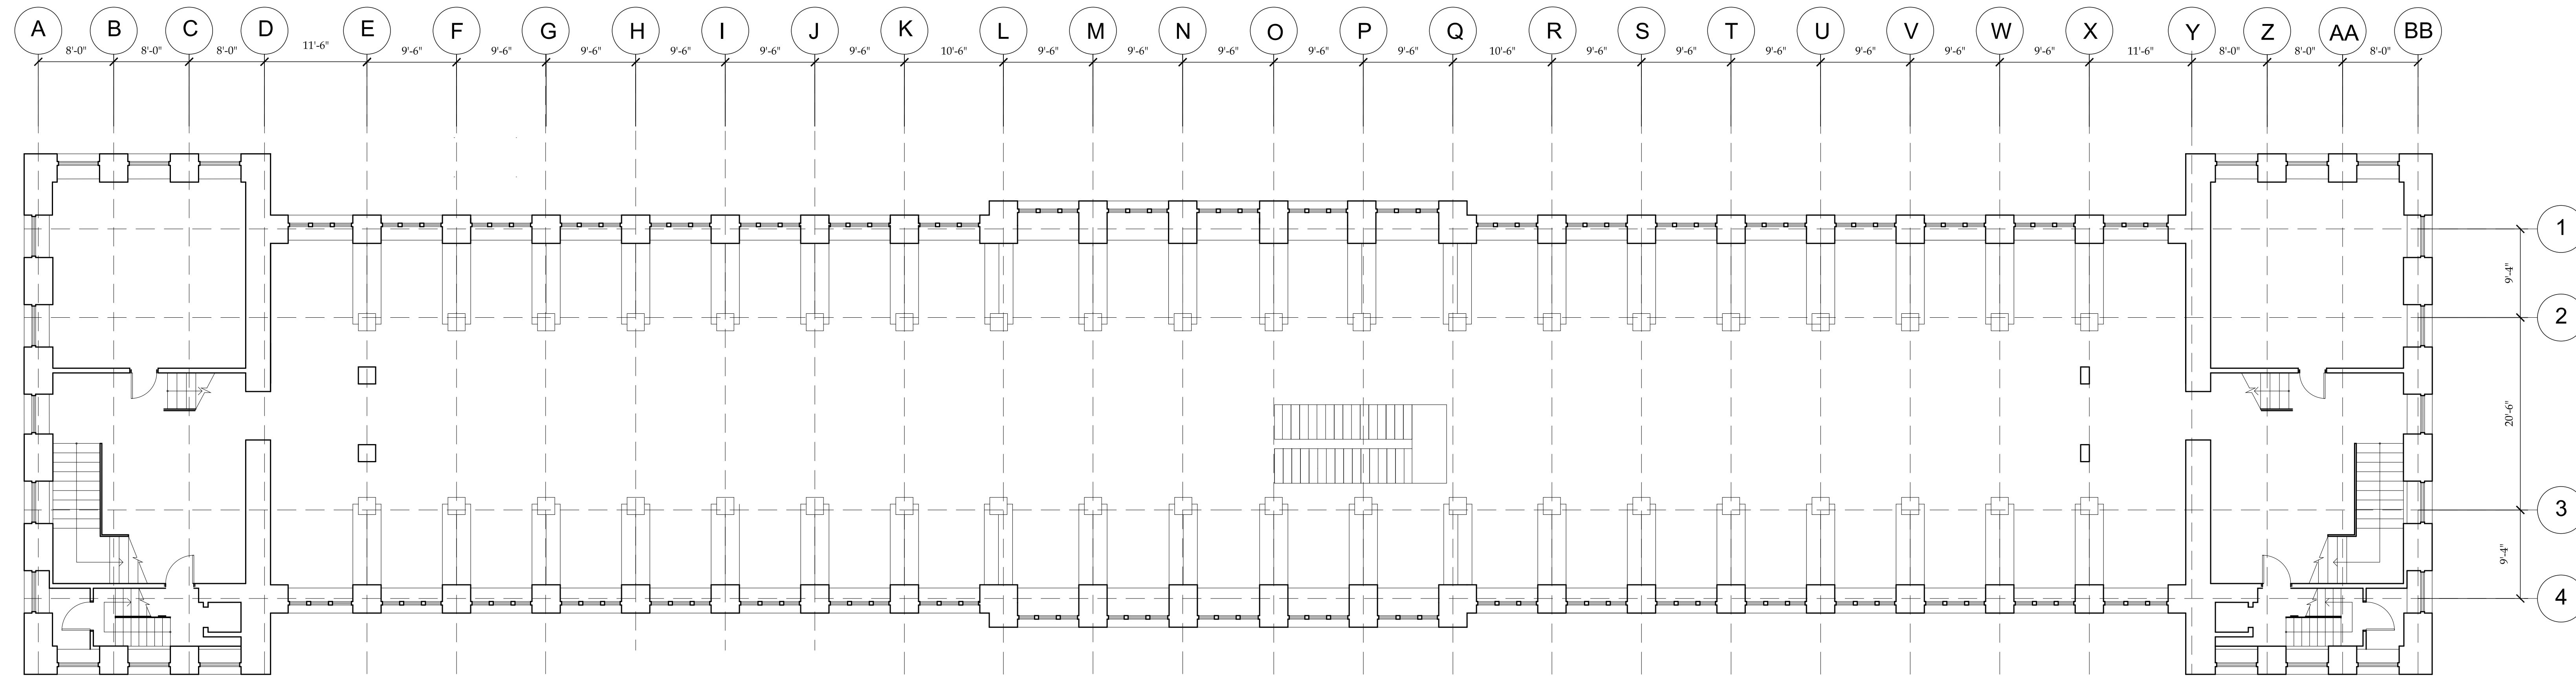

DATE OF FIRST ISSUE: MONTH DD, YYYY

|         |  |
|---------|--|
| 5/20/17 |  |
|         |  |
|         |  |
PROJECT  
**MAJOR CASE STUDY**

DWG TITLE  
**MEZZANINE FLOOR PLAN**

SEAL & SIGNATURE

DATE: **2017 05 26**

PROJECT NO.: **YYYY\_NN**

DRAWING BY: **YING REN**

CHK BY: **JAM / TMA**

DWG NO.: **A-102.00**

CAD FILE NO.: **XXX-101.00\_XXXX** PAGE: **3 OF 8**